


- Swimming Pool
- Athletics Coaches
- Sport Training Facilities

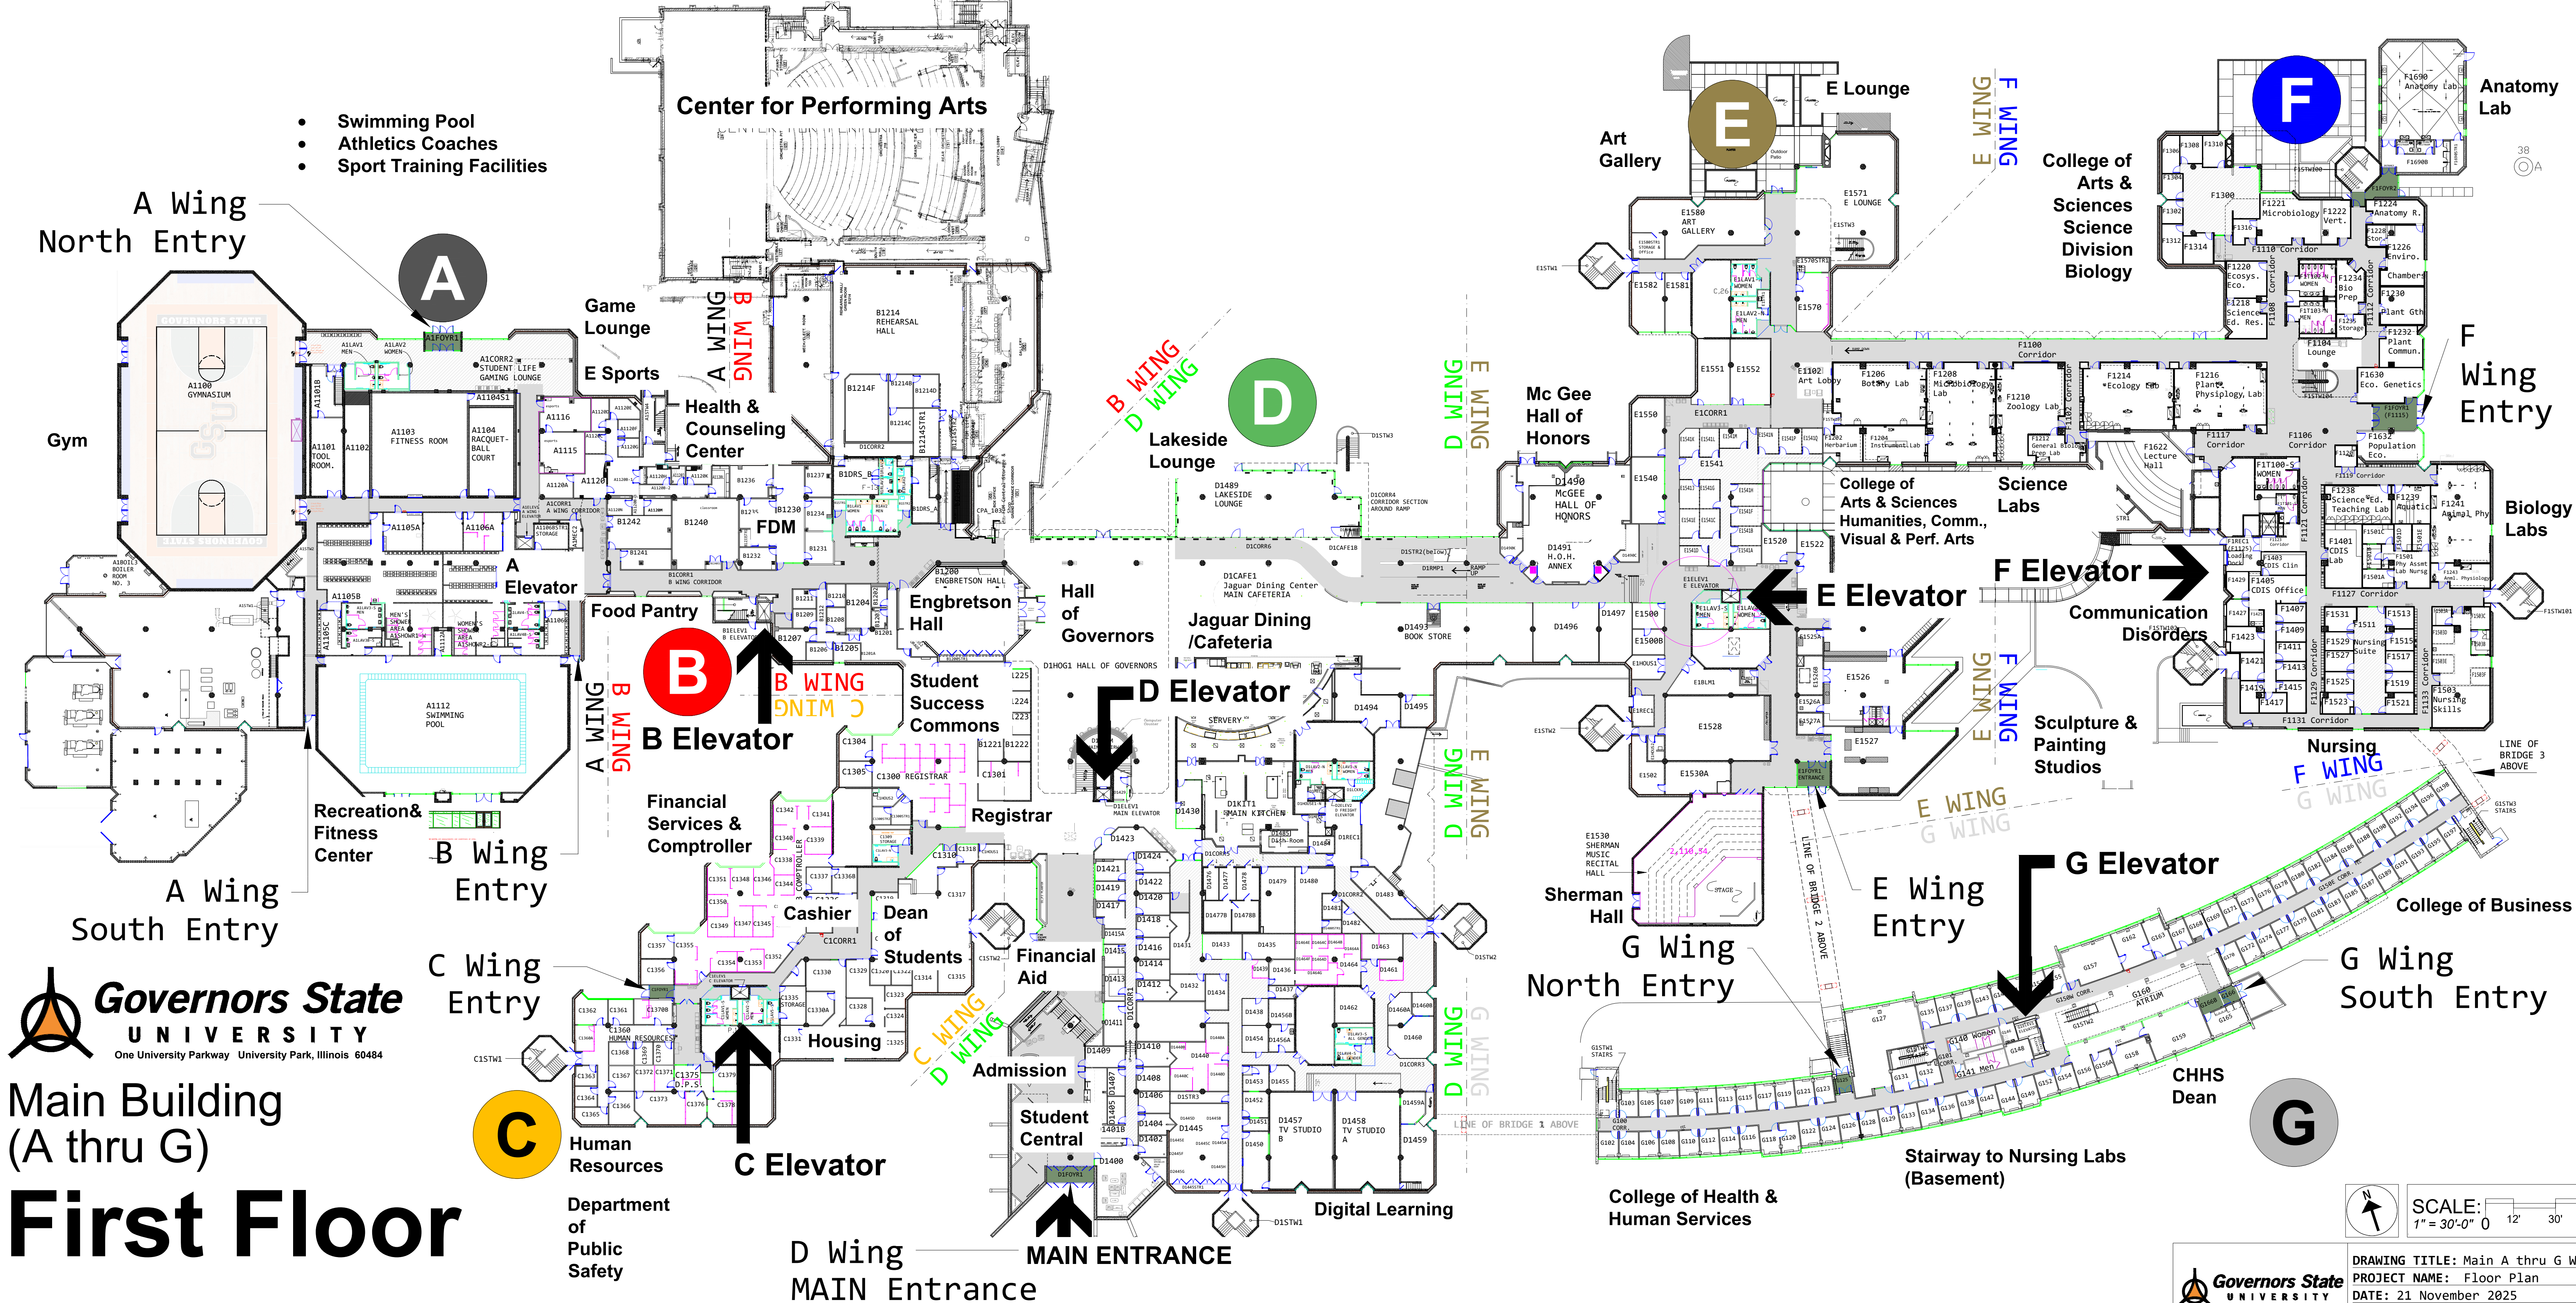

Main Building (A thru G) First Floor

C

C Elevator

Human Resources
Department of Public Safety

D Wing MAIN Entrance

MAIN ENTRANCE

G

G Elevator



DRAWING TITLE: Main A thru G Wing
PROJECT NAME: Floor Plan
DATE: 21 November 2025
DRAWN BY: L. Schultz CHECKED BY:

